



Addendum, Change Order, ^(JACHAN)
 Drawing, Deferred Approval
 Worksheet and Transmittal Memo

New Resubmittal Date Sent: 3/10/09 File # 1-C2 Appl. # 01-109151

Job
 Chabot College Modernization Bldg 300 & 500

Addendum Number	Deferred Submittal	Preliminary Change Order	Change Order Number	Other
5				

List of Material Received:	A. Master Copy (1) Addendum No. 5 w. AD2-C, AD2-E1 and AD2-F1	
	B. Copies (2) Addition copies of Addendum No. 5 w. AD2-C, AD2-E1 and AD2-F1	
	C. Tracing(s) each	of Sheets(s) Numbers(s)
	D. Prints(s) each	of Sheets(s) Numbers(s)
	E.	
	F.	

RECEIVED
 MAR 16 2009
 HMC ARCHITECTS

List of Material Approved:

List of Material To: Architect Structural Engineer

Name: **HMC ARCHITECTS**
 Address: 1570 The Alameda, Suite 330
 San Jose, CA 95126

Sent
 Handed
 Faxed

Carmen Torres	
To	From
HMC Architects	
Co.	No. of Pages
408-977-9170	408-977-9160
Fax No.	Phone No.

Item _____
 Copies TWO (2) copies

kj 3/12/2009

Remaining Requirements: Corrections Required Change Order Required

- If Corrections are required, please submit the following:
- 1) Intact marked up check set.
 - 2) This transmittal memo.
 - 3) Two corrected copies of submittal.
 - 4) Calculations and other back-up information.
 - 5) Drawings bearing preliminary approval stamps to avoid re-review whenever possible.

None

Remarks:

Notes for Clerical Use Only:
 Please make file copy of: transmittal Other: _____
 Extend Plans and specs approval to cover: _____
 Revised Plans and Specs.
 Additional: Plans and Specs. Scope increase: _____
 Type of Approval: _____

Scan for file!

Checked by	ACS <input checked="" type="checkbox"/> Not Required	FLS <input checked="" type="checkbox"/> Not Required	SSS <input type="checkbox"/> Not Required
Approved by			<u>J. Chan</u> <u>P. Chan</u>
Date			<u>3/11/09</u>

HMC ARCHITECTS
1570 The Alameda, Suite 330
San Jose, California 95126



March 6, 2009

Chabot College Modernization
of Buildings 300 and 500
Chabot-Las Positas Community College District
HMC # 3342002, DSA #01-109151

ADDENDUM NO. 5

The following changes, additions, deletions or corrections shall become a part of the Contract Documents for the project named above and all other conditions shall remain the same. The bidders shall be responsible for transmitting this information to all affected subcontractors and suppliers prior to the closing of bids.

GENERAL CLARIFICATION

All Scope of Work related to "Building 300" will NOT be part of this Bid Package.

DRAWINGS

Item No. AD-5.1: Reference Revised Drawings

- A. The following revised drawings are hereby issued that were missing from the Addendum No. 2.

AD2-C1
AD2-E1
AD2-F1


HMC ARCHITECTS

By _____
Lee Salin, AIA

APPROVED
DIV. OF THE STATE ARCHITECT

AC _____ F/LS _____ SS JCham
APPL. NO. 01-109151 DATE 3/11/09
FILE NO. 1-C2



FILE # 1-C2
 DSA # 01-109151

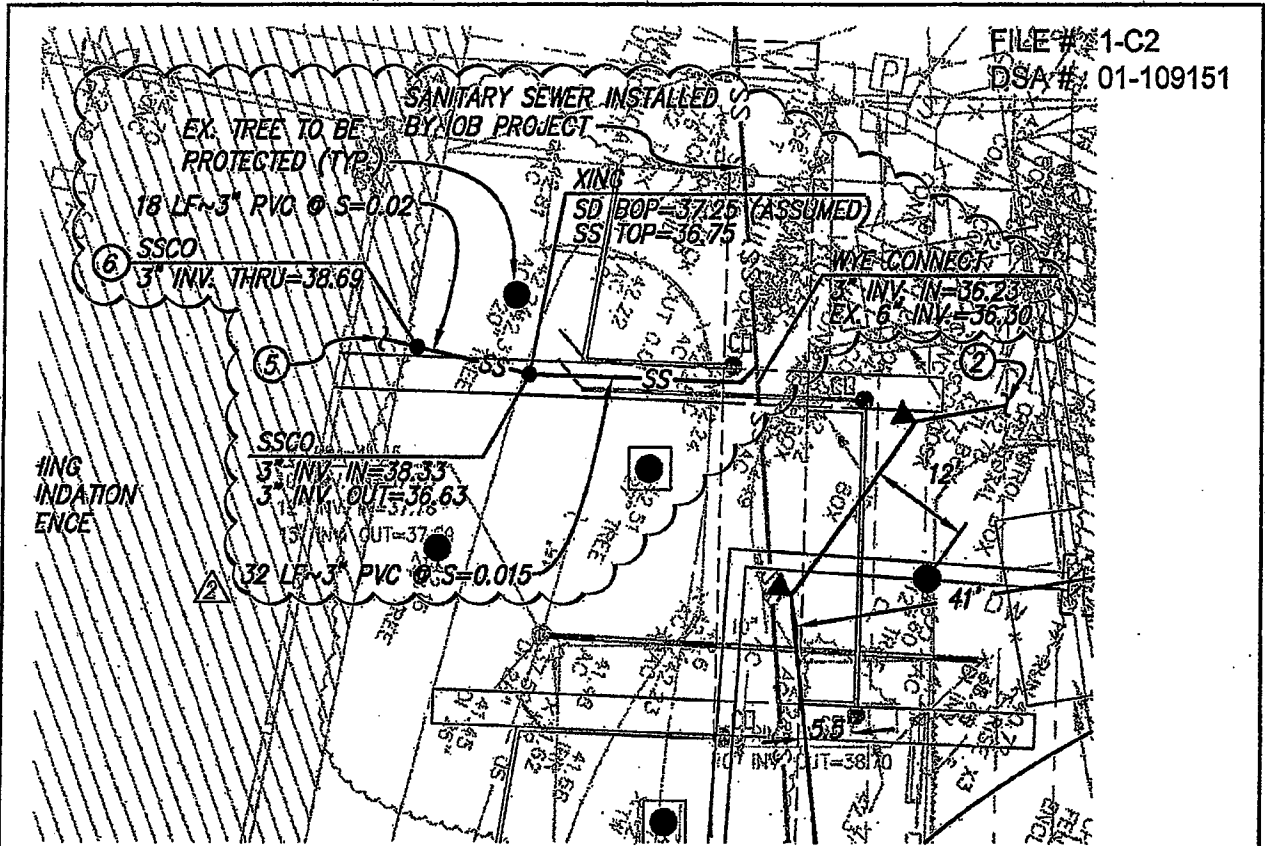

GRAPHIC SCALE



1 inch = 20 ft.

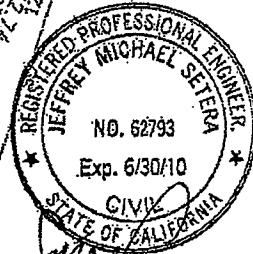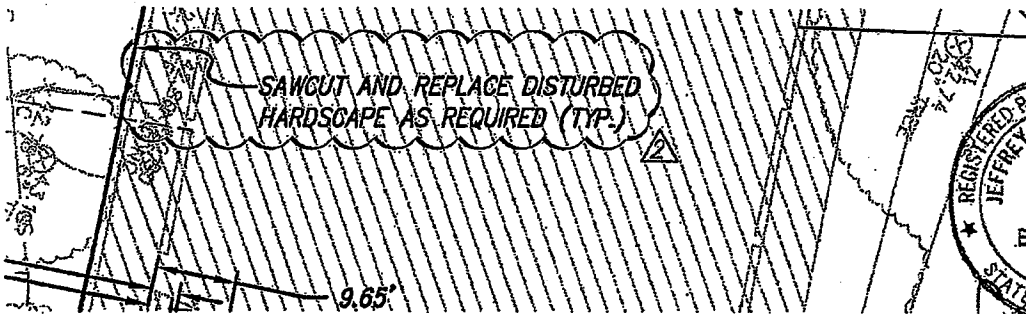

**CHABOT COLLEGE MODERNIZATION
 OF BUILDINGS 300, 500**

25555 HESPERIAN BLVD., HAYWARD, CA. 94545

CHABOT-LAS POSITAS COMMUNITY COLLEGE DISTRICT
 5020 FRANKLIN DRIVE, PLEASANTON, CA 94588




1570 THE ALAMEDA, Suite 330
 SAN JOSE, CALIFORNIA 95126
 Telephone: (408) 977-9100 Fax: (408) 977-9170

ADDENDUM # 2

Scale 1"=20'	Project No. 3342002
Ref. sheet No. C401	Date 01/12/09
	Drawing No. AD2-01

FILE #: 1-C2
 DSA #: 01-109151

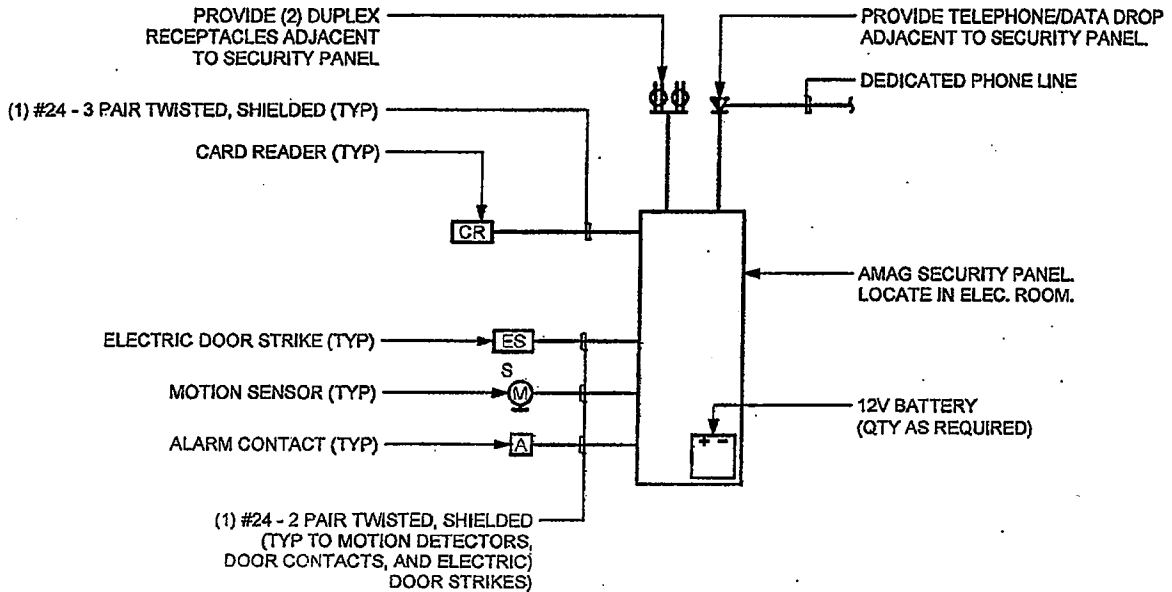


DETAIL NOTES

1. QTY OF DEVICES ARE INDICATED ON DRAWINGS.
2. ALL WIRING SHALL BE RUN IN CONDUIT.
3. DIAGRAM IS TYPICAL FOR BUILDING 300 AND 500.
4. CONTRACTOR SHALL PROVIDE END OF LINE RESISTORS (AS REQUIRED) TO ENSURE INDIVIDUAL ANNUNCIATION OF FIELD DEVICES

4 SECURITY RISER DIAGRAM
 NOT TO SCALE



File Name: P:\Projects\HMC Chabot CS Bldg 300 & 500 Modernization 06051\Drawings\06051E00.dwg Jan 08, 2009 - 12:58pm

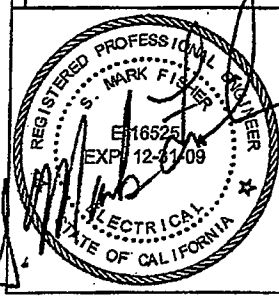

CHABOT COLLEGE MODERNIZATION OF BUILDINGS 300, 500

25555 HESPERIAN BLVD., HAYWARD, CA. 94545
 CHABOT-LAS POSITAS COMMUNITY COLLEGE DISTRICT
 5020 FRANKLIN DRIVE, PLEASANTON, CA 94588

HMC 1570 THE ALAMEDA, Suite 330
 SAN JOSE, CALIFORNIA 95126
 Telephone: (408) 977-0160 Fax: (408) 977-0170

ADDENDUM # 2

Scale 1/8" = 1'-0"	Project No. 3342002
Ref. sheet No.	Date: 01.12.09
E6.0	Drawing No. AD2-E1

SEQUENCE OF OPERATION OF FIRE ALARM SYSTEM

FILE #: 1-C2
DSA #: 01-109151

2

- ACTIVATION OF ANY SYSTEM PULL STATION, SMOKE DETECTOR, HEAT DETECTOR, OR WATER FLOW SWITCH SHALL CAUSE ALL SIGNAL DEVICES WITHIN THE AFFECTED BUILDING TO ACTIVATE AND SOUND (CFC 907.2.3.1 EXCEPTION 1 AND 2). FACP(S) AND REMOTE ANNUNCIATOR(S) SHALL INDICATE THE SOURCE OF THE ALARM AND ALARM LIGHT(S) ON THE FIRE ALARM PANEL WILL ILLUMINATE. ACTIVATION OF ALARM SHALL CAUSE THE DIGITAL ALARM COMMUNICATIONS TRANSMITTER TO TRANSMIT THE ALARM TO A U.L. LISTED CENTRAL STATION.

IN ADDITION:

- ACTIVATION OF AN AHU DUCT SMOKE DETECTOR SHALL SHUT DOWN THE ASSOCIATED AHU VIA A RELAY BASE.

GENERAL NOTES

- AUDIBLE SIGNALS INTENDED FOR OPERATION IN THE PUBLIC MODE SHOULD HAVE A SOUND LEVEL OF NOT LESS THAN 75 dBA AT 10 FEET OR MORE THAN 110 dBA AT THE MINIMUM HEARING DISTANCE FROM THE AUDIBLE APPLIANCE. (CBC SECTION 3501.1)

2


- FINAL FIRE ALARM TEST SHALL BE MADE WITH THE DSA INSPECTOR OF RECORD (IOR) AND COLLEGE'S COMMISSIONING AGENT (PPS) PRESENT. LOCAL FIRE AUTHORITY SHALL BE NOTIFIED OF DATE AND TIME OF FINAL FIRE ALARM TESTING AND SHALL ASSIST/WITNESS SUCH TESTING AT THEIR DISCRETION.

- FIRE ALARM CONTRACTOR SHALL PROVIDE A "RECORD OF COMPLETION" TO THE INSPECTOR OF RECORD (IOR)/DSA AFTER COMPLETION OF OPERATIONAL ACCEPTANCE TESTS. (1999 NFPA 72 SECTION 1-6.2.1 AND FIGURE 1-6.2.1)


- THE SUPERVISORY STATION SHALL BE LISTED AS EITHER UUFX OR UUJS BY UNDERWRITERS LABORATORIES OR SHALL MEET THE REQUIREMENTS OF FACTORY-MUTUAL RESEARCH APPROVAL STANDARD 3011.

2

- ALL PROGRAMMING OF FIRE ALARM CONTROL PANEL SHALL BE COMPLETED BY COLLEGE'S COMMISSIONING AGENT (PPS). FIRE ALARM SUBCONTRACTOR SHALL PROVIDE AS-BUILT DRAWING AND LIST OF DEVICES TO COMMISSIONING AGENT PRIOR TO PROGRAMMING.

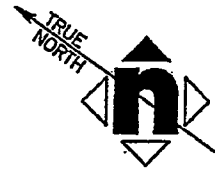

File Name: P:\Projects\HMC Chabot CC Bldg 300 & 500 Modernization 06051\Drawings\06051FPO.dwg Jan 08 2009 - 4:01 pm

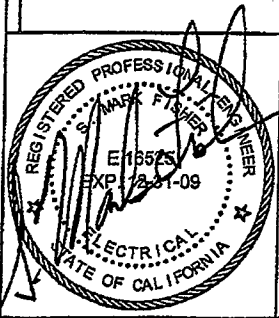

**CHABOT COLLEGE MODERNIZATION
OF BUILDINGS 300, 500**
25555 HESPERIAN BLVD., HAYWARD, CA. 94545

CHABOT-LAS POSITAS COMMUNITY COLLEGE DISTRICT
5020 FRANKLIN DRIVE, PLEASANTON, CA 94588

HMC 1570 THE ALAMEDA, Suite 330
SAN JOSE, CALIFORNIA 95126
Telephone: (408) 977-9160 Fax: (408) 977-9170

ADDENDUM # 2	
Scale 1/8" = 1'-0"	Project No. 3342002
Ref. sheet No. F0.0	Date 01.12.09
	Drawing No. AD2-F1