

Safe Work Practice Zones

Chabot College – Building 3200 1st Floor
25555 Hesperian Blvd., Hayward, CA
FACS #PJ48098
May 11, 2021


LEGEND

Green = staff personal spaces	Light Purple = common areas
Yellow = staff common areas	Dark Purple = public specialized areas
Orange = staff specialized areas	





NOTE: PAVIC HATCHING IS NOT REQUIRED IN ELEC ROOMS PER DEC 118.26(C)(3) WHICH APPLIES IF TOTAL LOAD AT MAIN SWITCHBOARD IS LESS THAN TOTAL LOAD AT SINGLE LINE DIAGRAM IN E-001

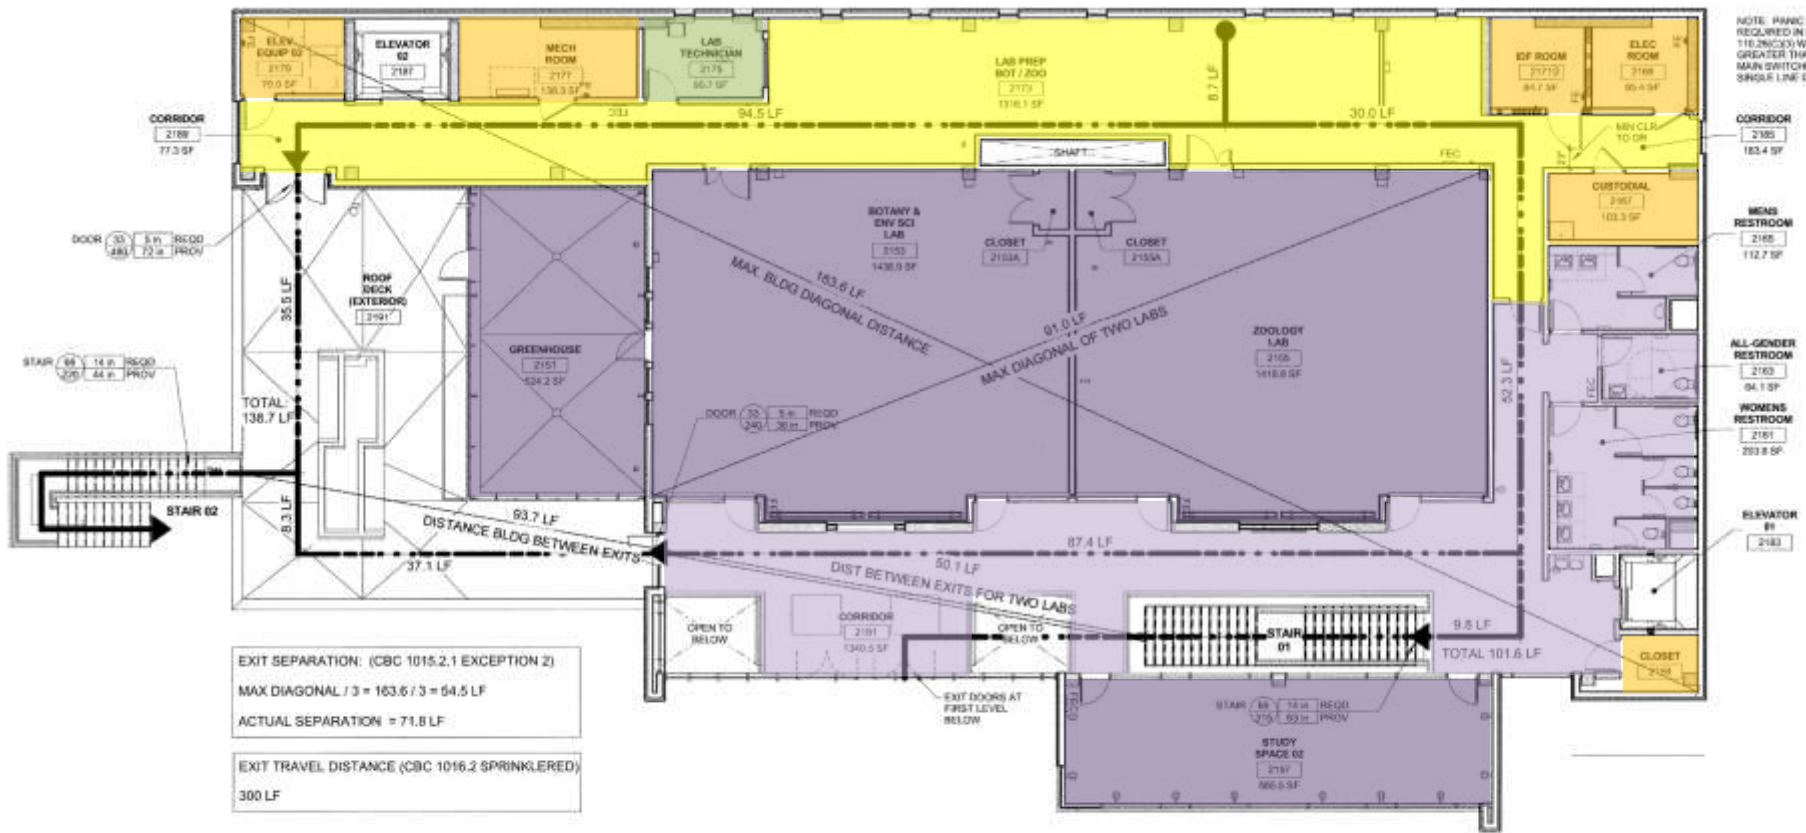

EXIT SEPARATION: (CBC 1015.2.1 EXCEPTION 2)
 MAX DIAGONAL / 3 = 163.6 / 3 = 54.5 LF
 ACTUAL SEPARATION = 71.8 LF

EXIT TRAVEL DISTANCE (CBC 1016.2 SPRINKLERED)
 300 LF

SECOND FLOOR EXITING PLAN
 SCALE: 1/8" = 1'-0"

Safe Work Practice Zones

Chabot College – Building 3200 2nd Floor
 25555 Hesperian Blvd., Hayward, CA
 FACS #PJ48098
 May 11, 2021

LEGEND

Green = staff personal spaces	Light Purple = common areas
Yellow = staff common areas	Dark Purple = public specialized areas
Orange = staff specialized areas	

